 



Consultants




SHEPHERD ENGINEERING, INC.
ELECTRICAL CONSULTANTS

1308 GRAFTON STREET
WORCESTER, MASSACHUSETTS 01604
PHONE: (508) 757-7793 * FAX: (508) 753-2309
REFERENCE NO.: 18110

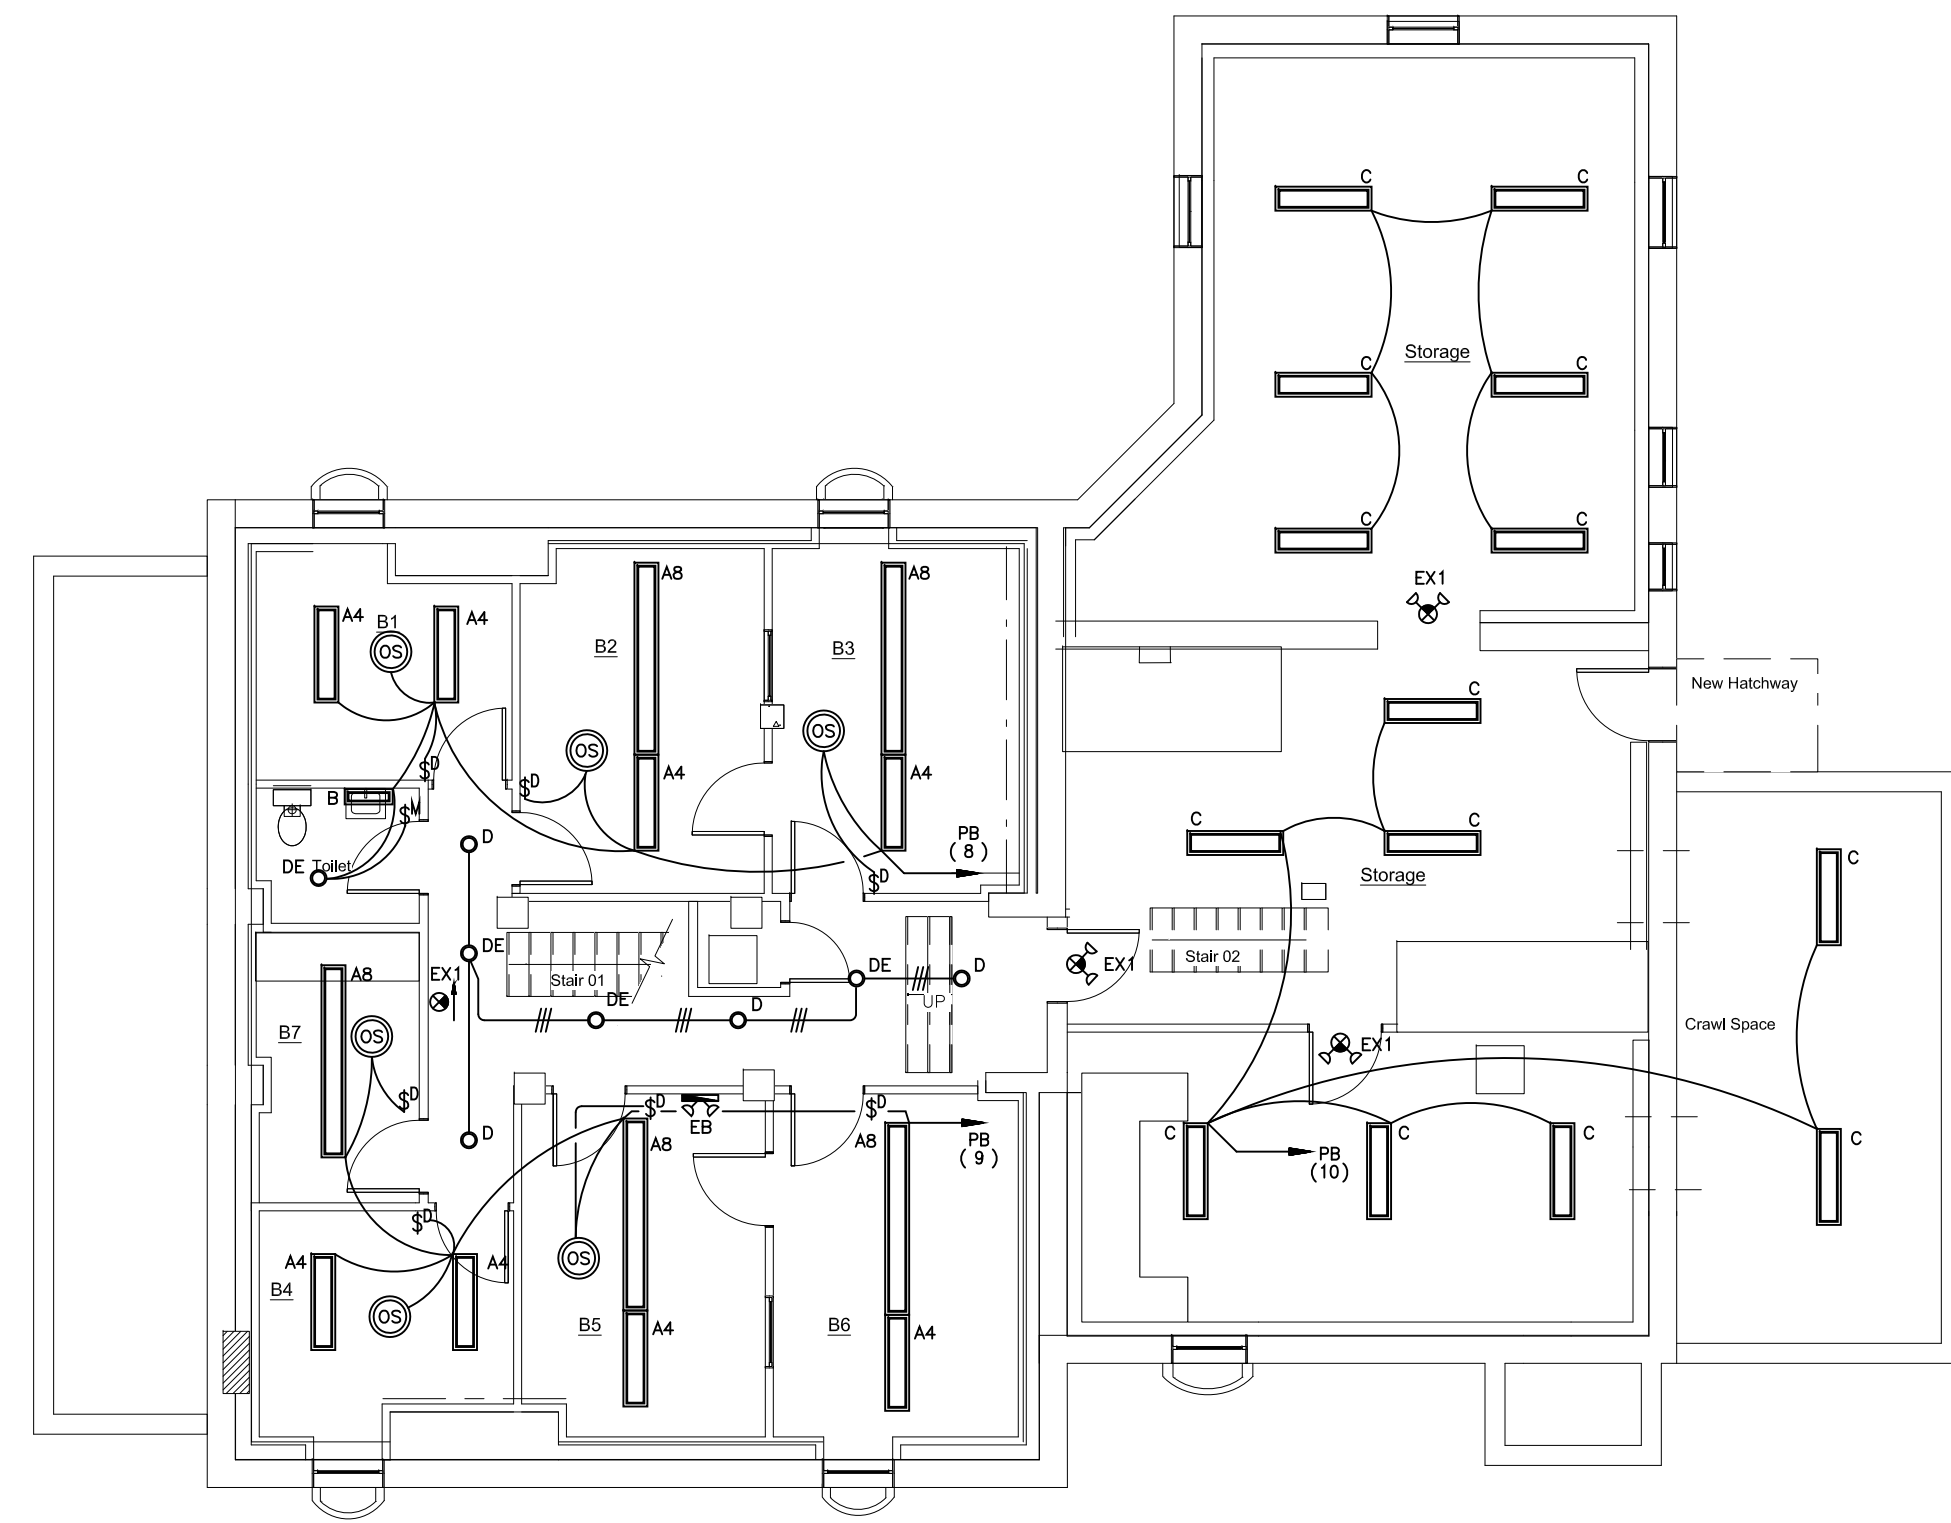


BASEMENT FLOOR PLAN - LIGHTING
Scale: 1/8"=1'-0"

NOTE:
EXIT SIGNS AND EMERGENCY BATTERY
UNITS ARE TO BE CONNECTED TO THE
LINE SIDE OF THE LOCAL LIGHTING CIRCUIT.

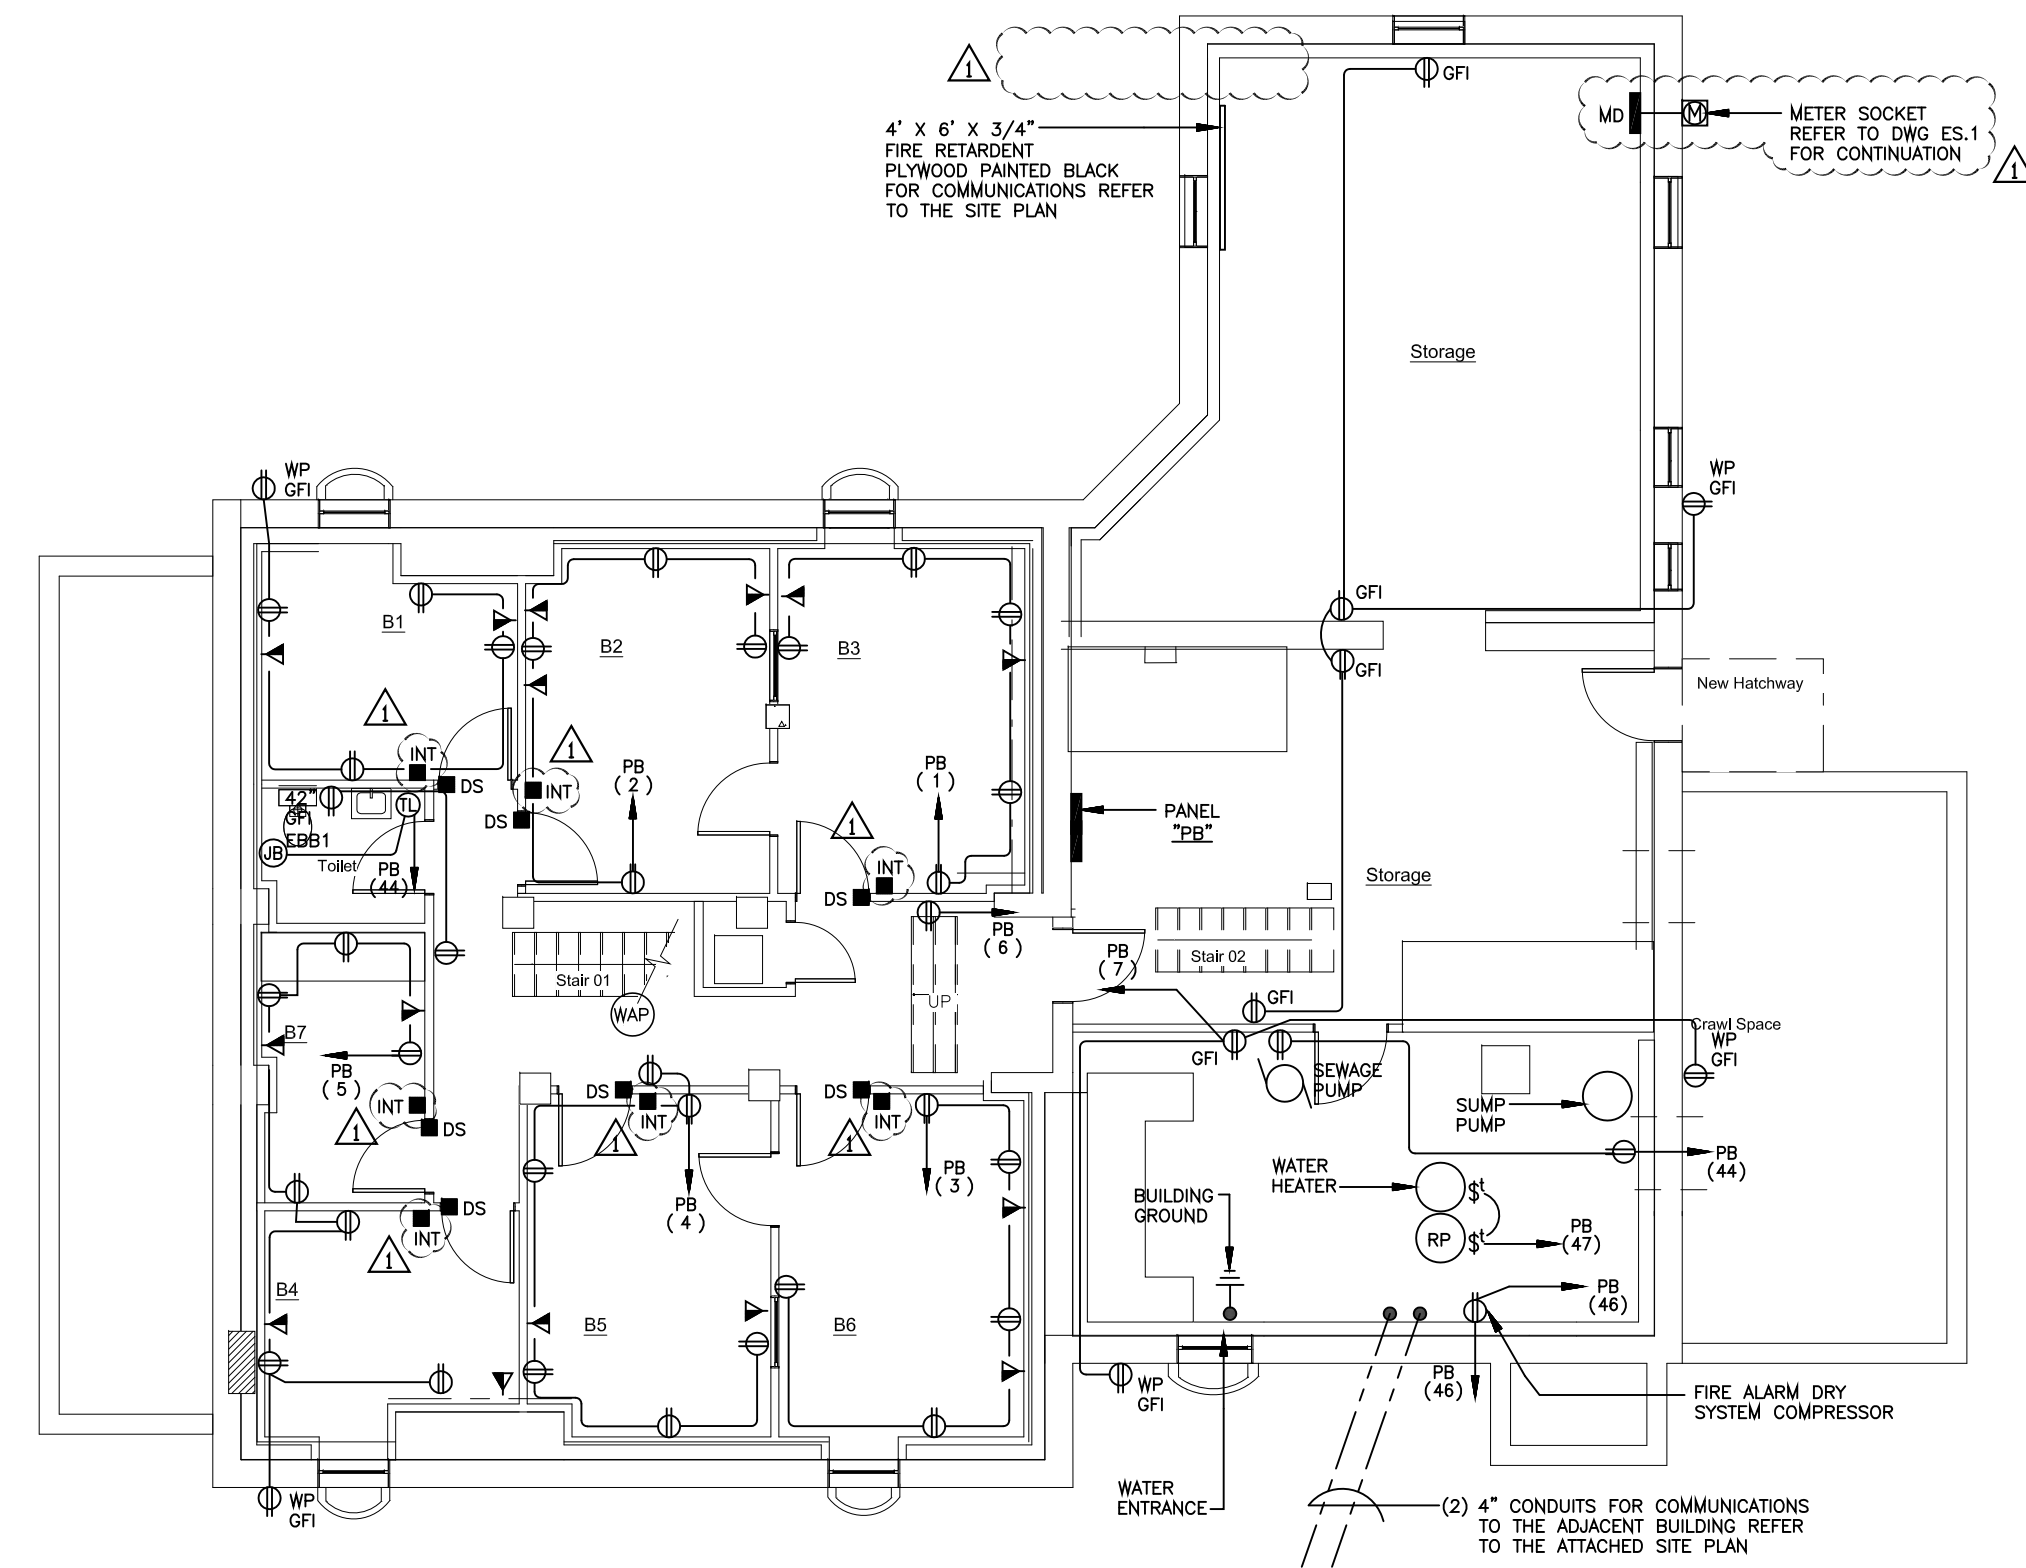

BASEMENT FLOOR PLAN - POWER
Scale: 1/8"=1'-0"

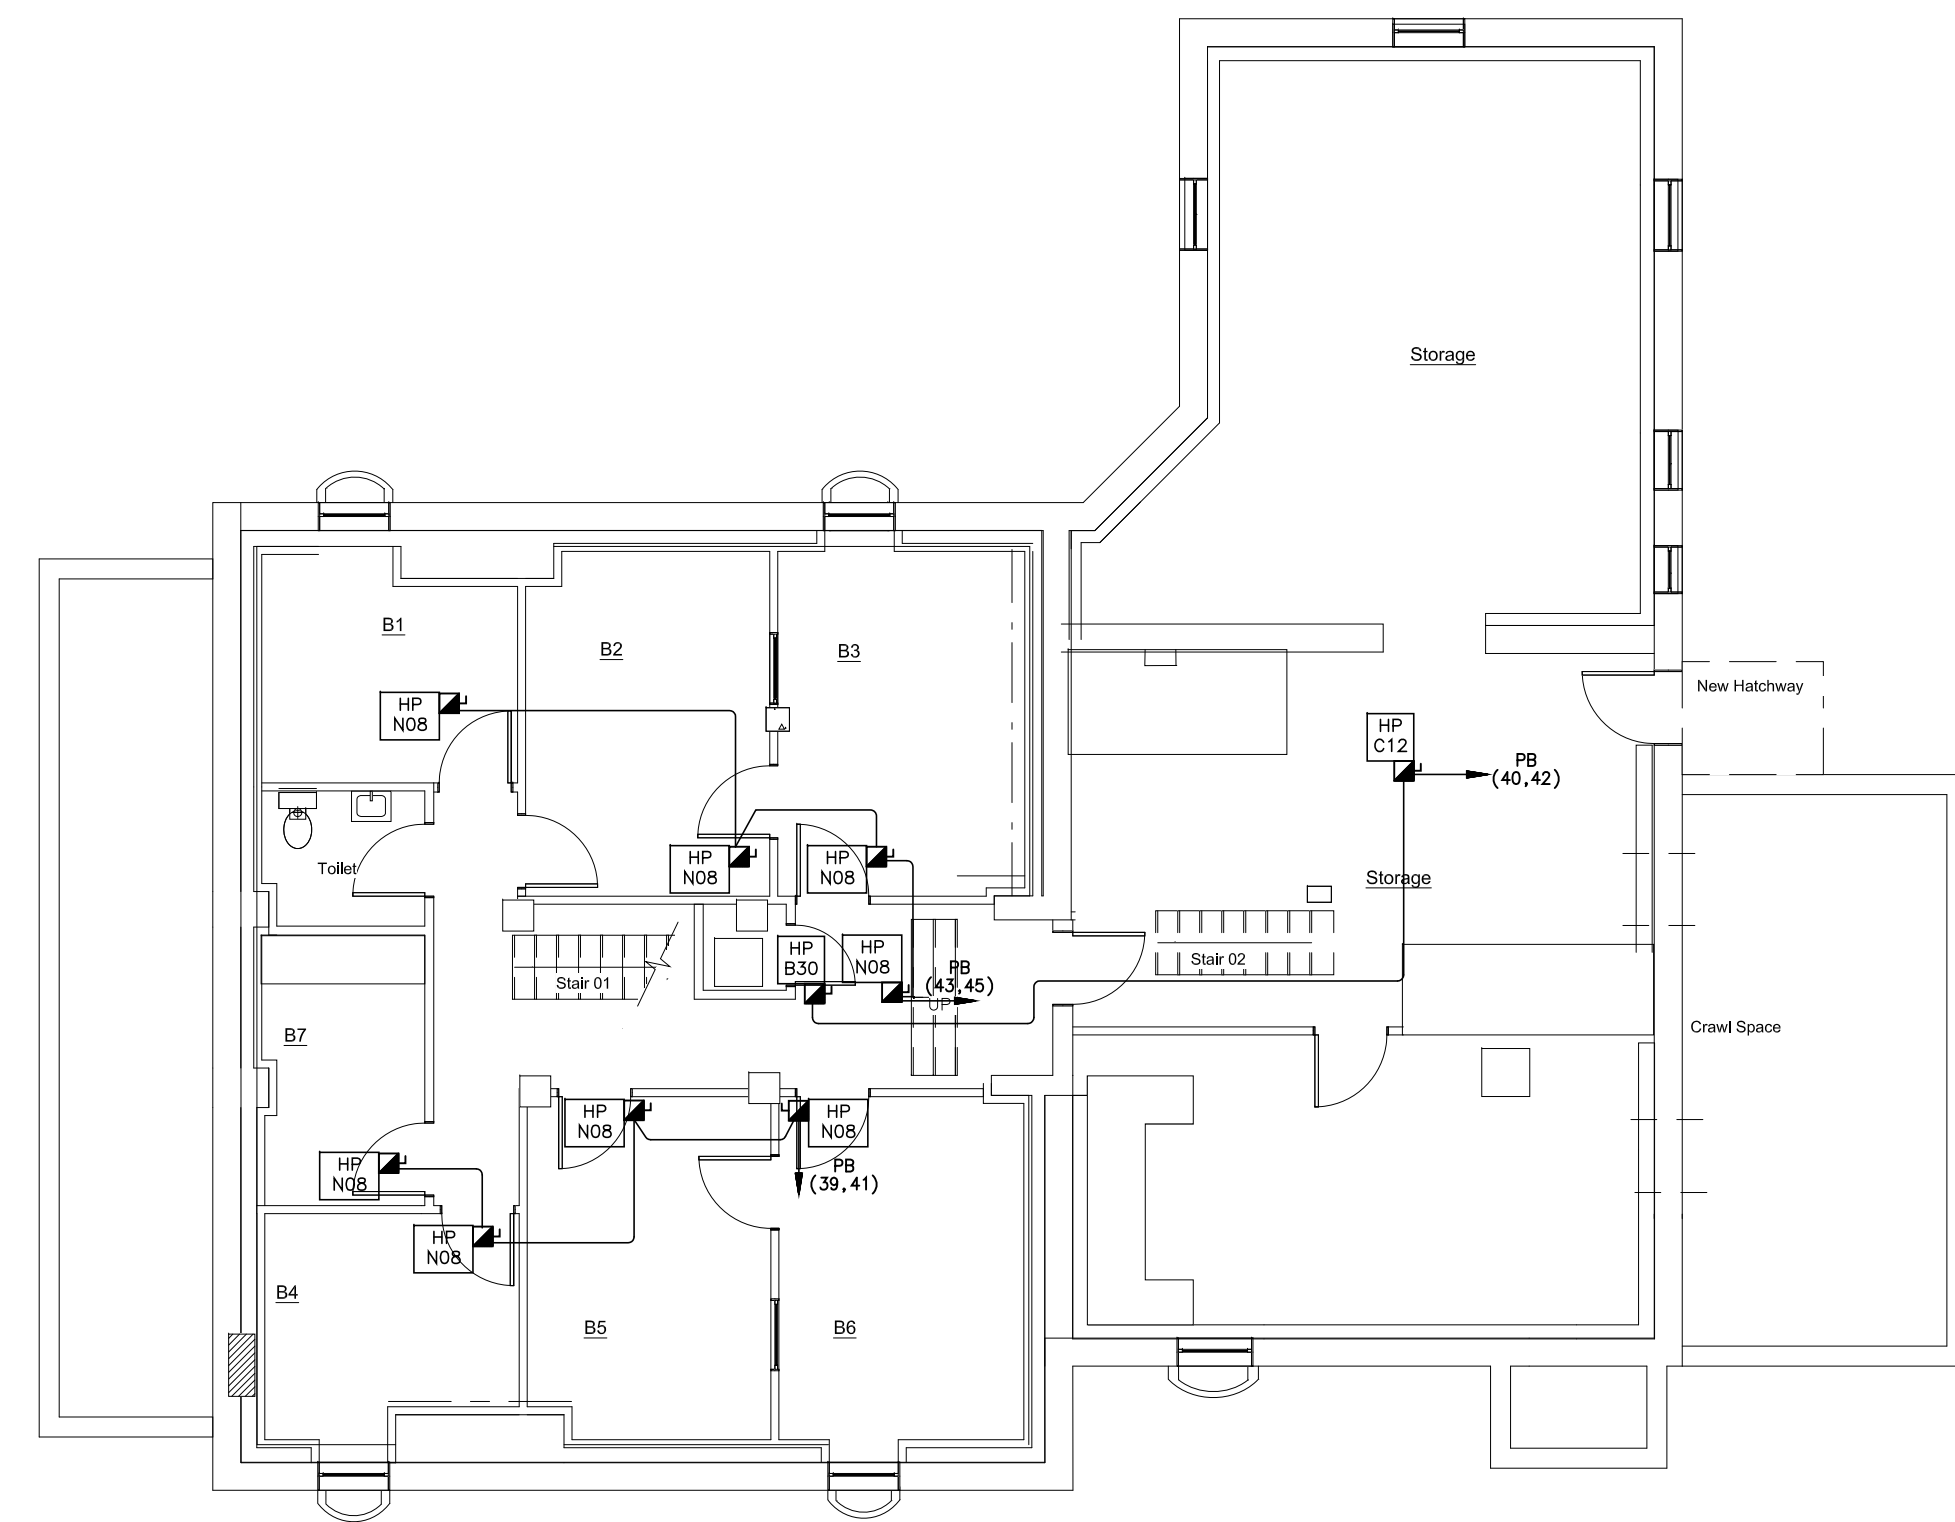

BASEMENT FLOOR PLAN - HVAC ELECTRICAL
Scale: 1/8"=1'-0"

77 Maple Street
SPRINGFIELD, MA

Basement Floor Plans
Lighting, Power and HVAC Electrical

Revisions:
ELECTRICAL REVISIONS 12/10/18

Date 10-18-2018
File Name 77 Maple Street
Drawn By AJV
Reviewed By JDS
Scale 1/8"=1'-0"

Drawing No.

E1.1

of